



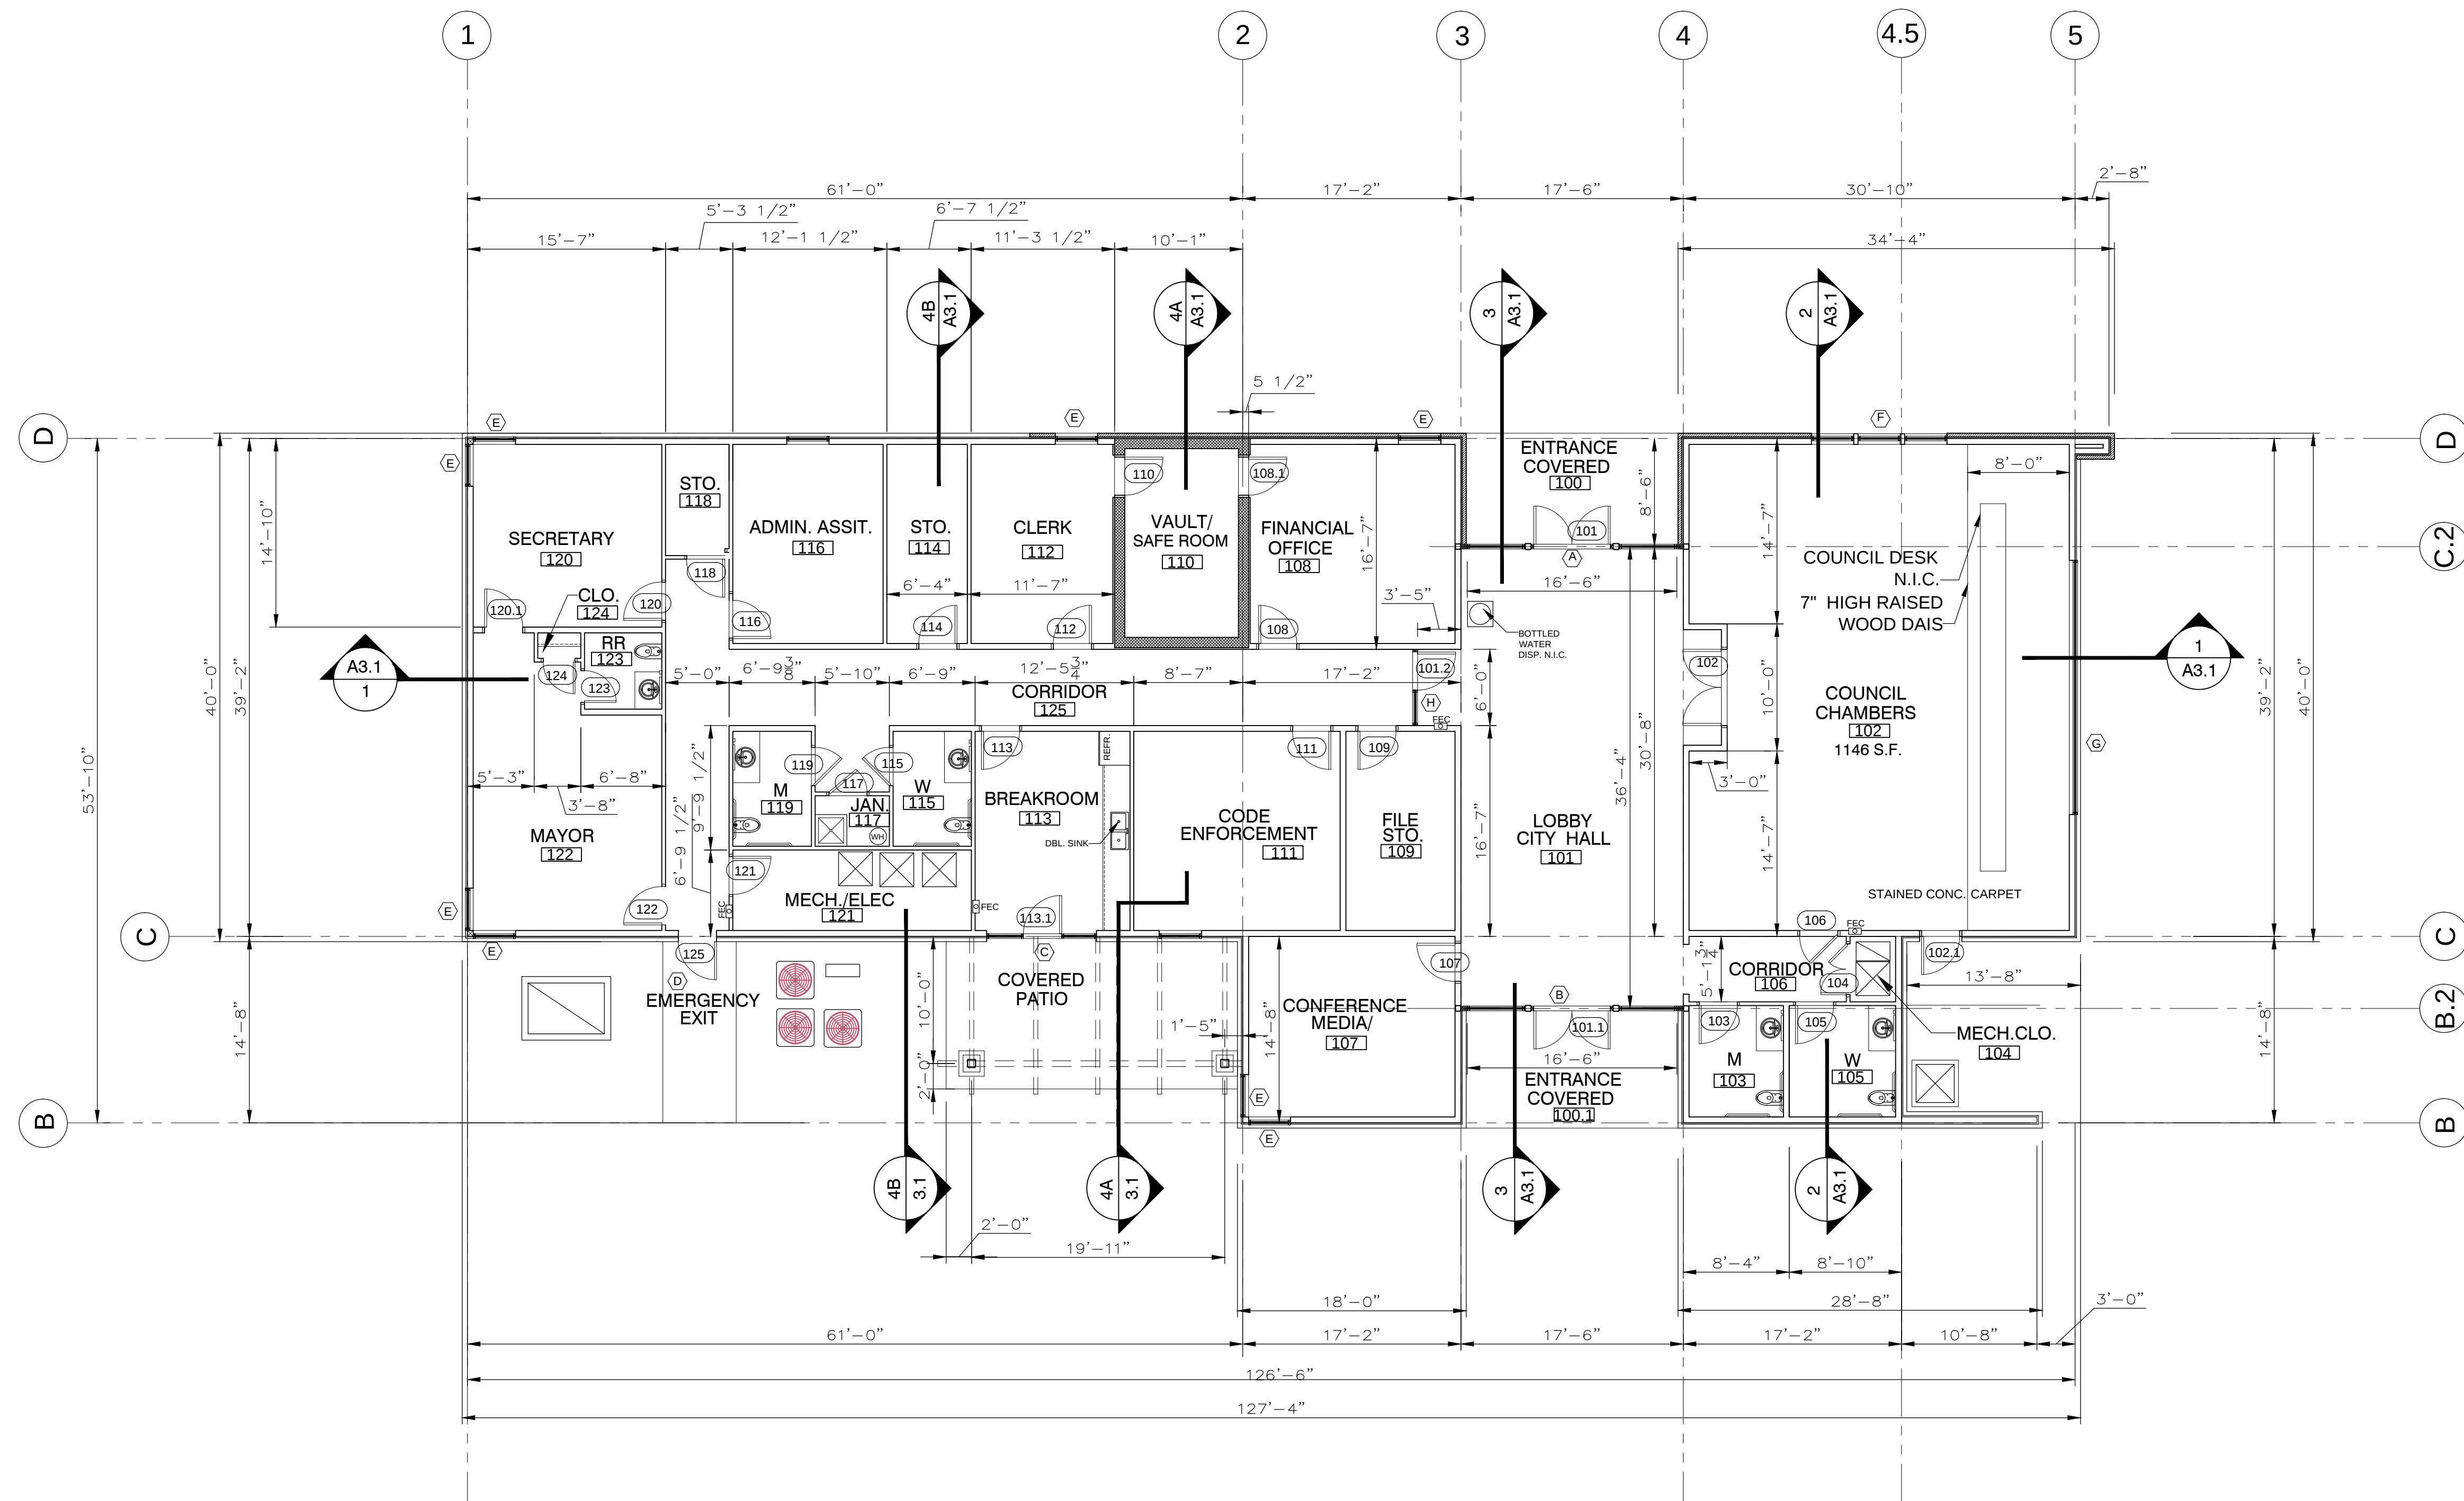

FLOOR PLAN

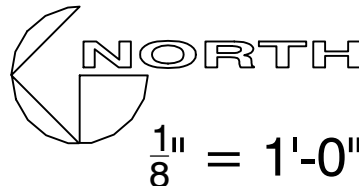

1/8" = 1'-0"

GEOTECHNICAL ENGINEER
MTA Engineers
A Division of Material Testings of Arkansas
P.O. Box 23715
Little Rock, AR 72221
Ph. 501.753.2526
Fax 501.753.5747



ETC ENGINEERS & ARCHITECTS, INC.
Environmental Technical Consultants, Inc.
ENGINEERING & ARCHITECTURAL CONSULTANTS, CONSTRUCTION MANAGERS
BUILDING A BETTER WORLD
1510 S. Broadway, Little Rock, AR 72202 Phone (501) 375-1786 FAX (501) 375-1277

**FORREST CITY
NEW CITY HALL**
FORREST CITY, AR

ISSUE / DATE	
DATE	DESCRIPTION
PROJECT NO.	163902CFC
PROJECT PHASE	CONSTRUCTION DOCUMENTS
DRAWN BY:	CHECKED BY:
GLA	GLA

FLOOR PLAN
NOVEMBER 8, 2016

A1.1