


JONESBORO MUNICIPAL AIRPORT

HANGAR REPLACEMENT


3001 EARHART DRIVE
JONESBORO, AR 72401

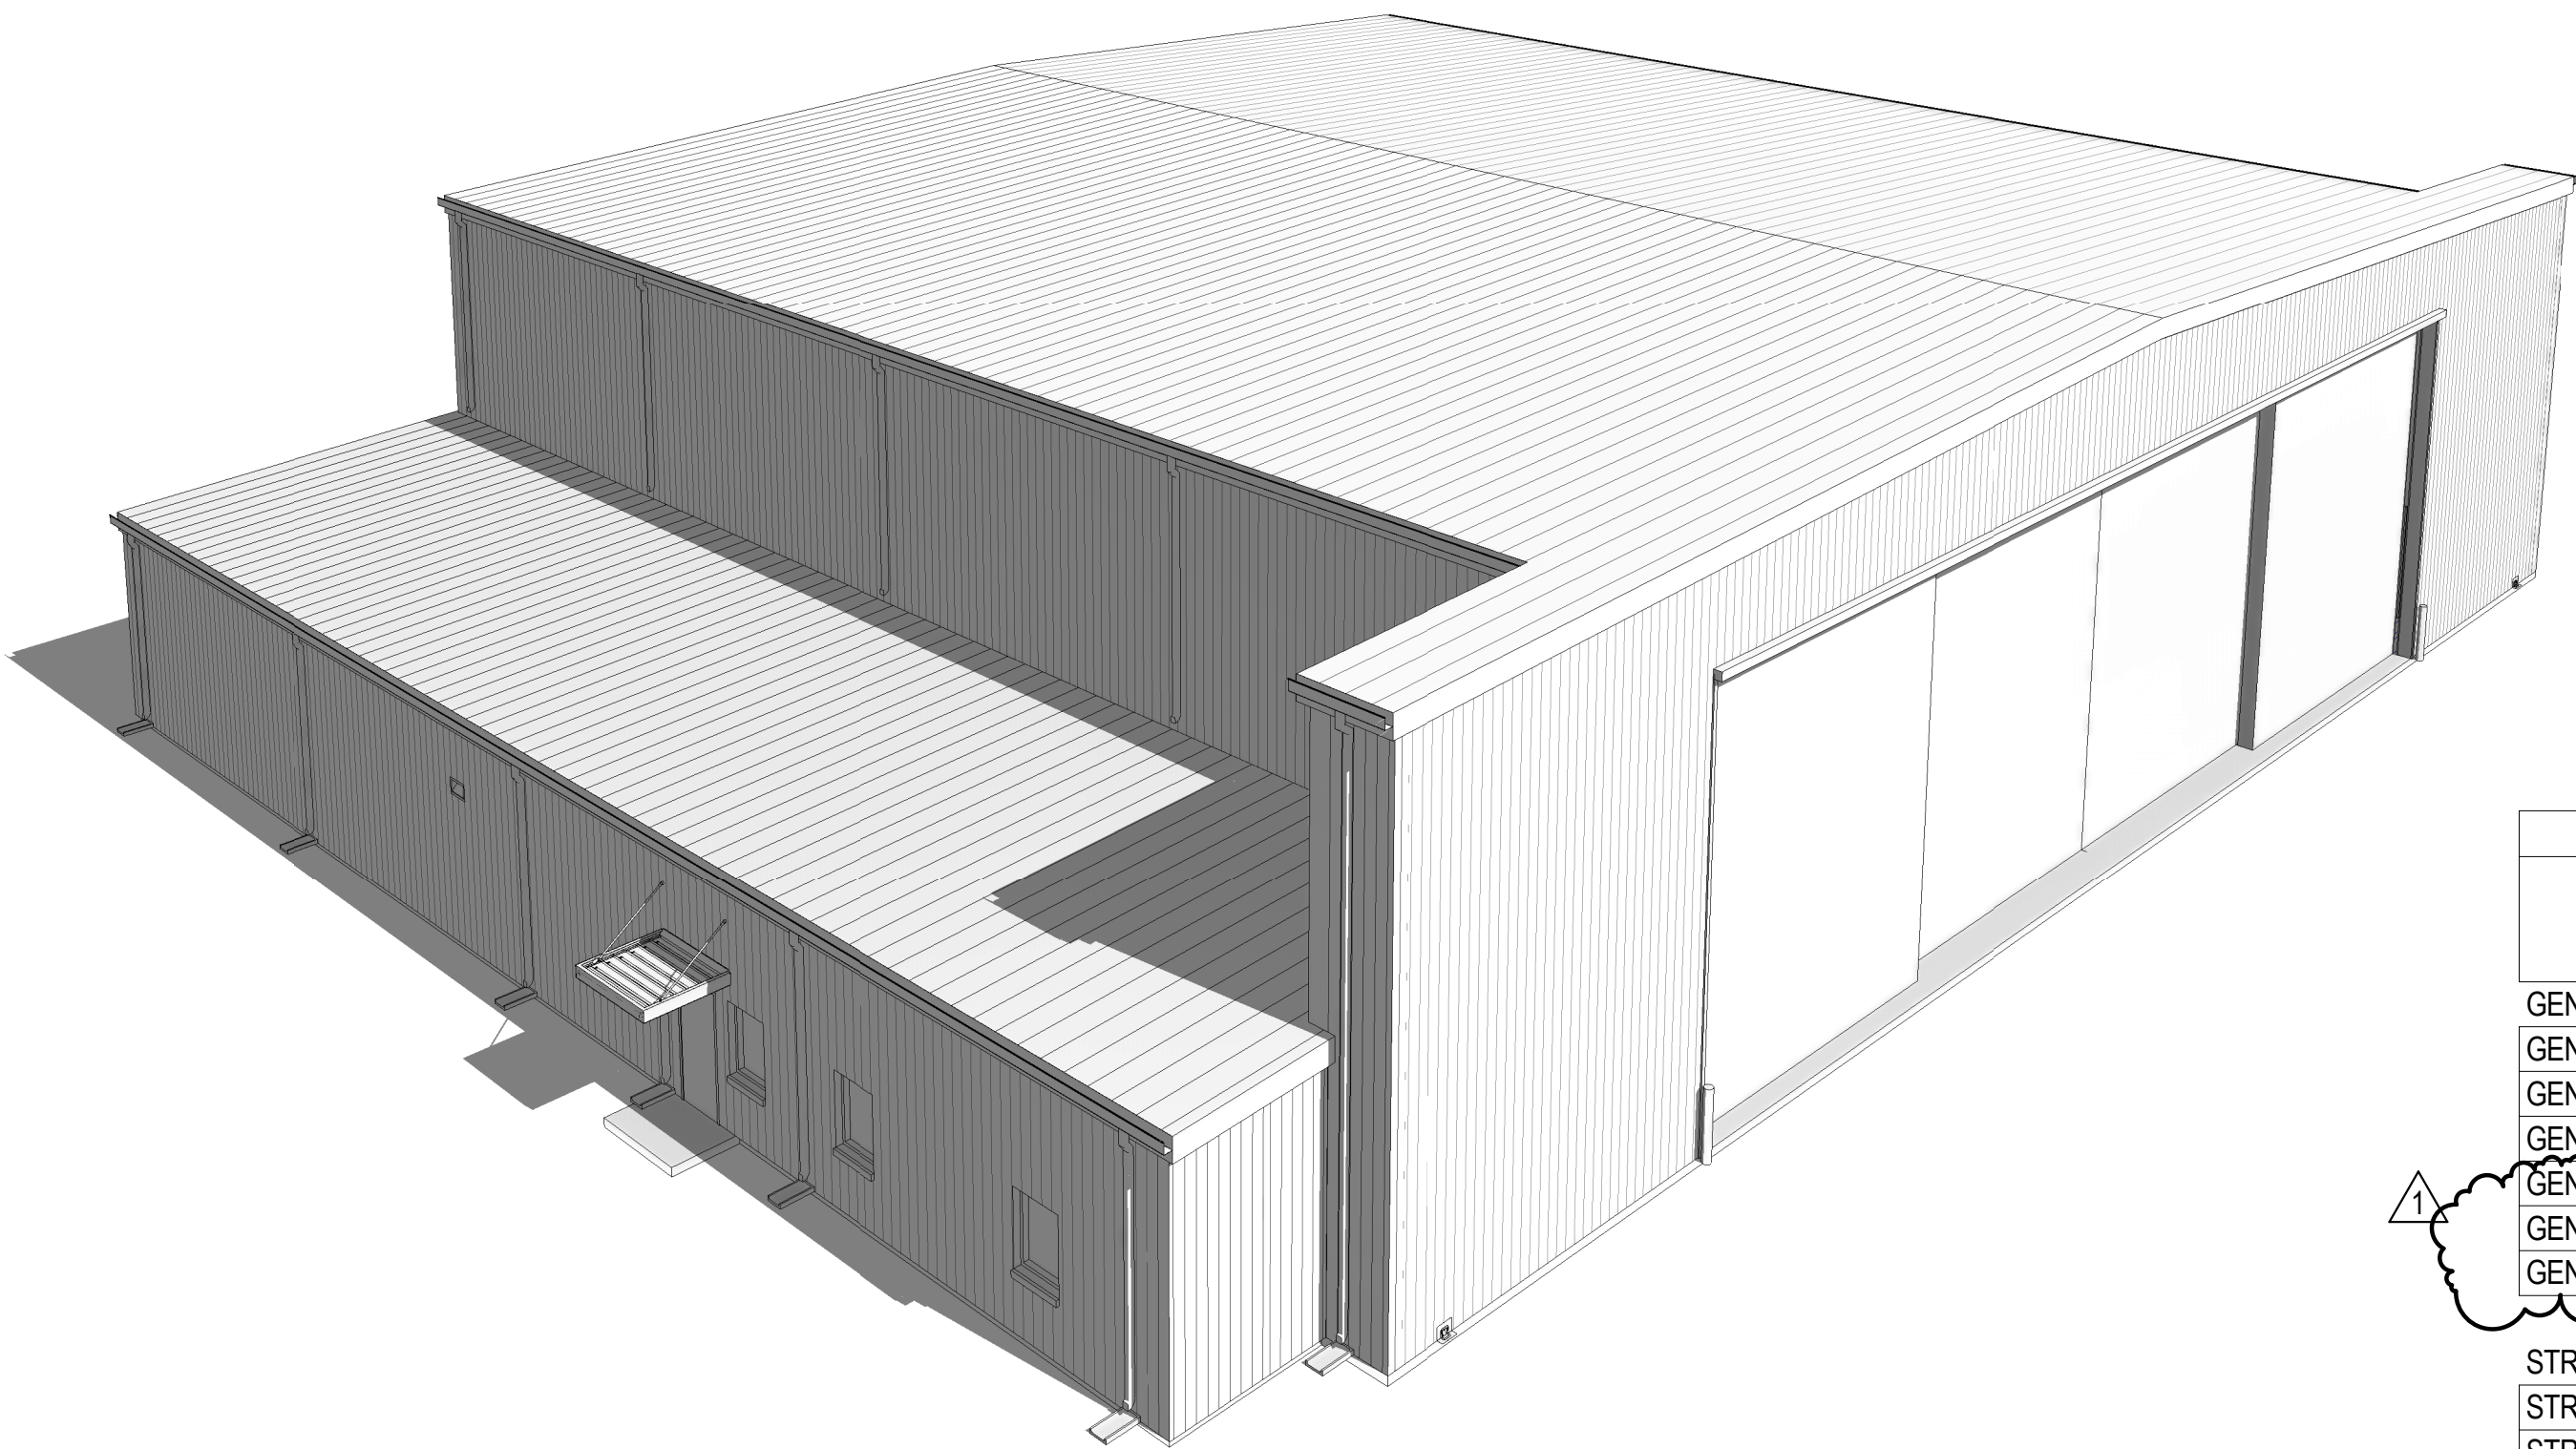

CONSTRUCTION SET
ADDENDUM #2
03-23-2021

SCHEDULE - SHEET INDEX			
DISCIPLINE	SHEET INFORMATION		SUBMISSIONS CONSTRUCTION SET
	NUMBER	NAME	
GENERAL			
GENERAL	G-001	COVER SHEET	X
GENERAL	G-101	GENERAL NOTES	X
GENERAL	G-102	CODE SCHEDULE & LIFE SAFETY PLAN	X
GENERAL	G-103	UL DESIGNS	X
GENERAL	G-104	UL DESIGNS	X
GENERAL	G-105	UL DESIGNS	X
STRUCTURAL			
STRUCTURAL	S-001	GENERAL NOTES	X
STRUCTURAL	S-101	FOUNDATION AND SLAB PLAN	X
STRUCTURAL	S-201	FOUNDATION SECTIONS AND DETAILS	X
ARCHITECTURE			
ARCHITECTURE	A-001	ARCHITECTURAL GENERAL NOTES, MATERIAL AND ANNOTATION LEGEND	X
ARCHITECTURE	A-002	TYPICAL ADA DETAILS	X
ARCHITECTURE	AD-110	DEMOLITION FLOOR PLAN	X
ARCHITECTURE	AS100	OVERALL SITE PLAN	X
ARCHITECTURE	AS-101	ARCHITECTURAL SITE PLAN	X
ARCHITECTURE	A-110	FLOOR PLAN	X
ARCHITECTURE	A-130	ROOF PLAN	X
ARCHITECTURE	AR110	REFLECTED CEILING PLAN	X
ARCHITECTURE	A-201	EXTERIOR ELEVATIONS	X
ARCHITECTURE	A-202	EXTERIOR ELEVATIONS	X
ARCHITECTURE	A-301	BUILDING SECTIONS	X
ARCHITECTURE	A-311	WALL SECTIONS	X
ARCHITECTURE	A-312	WALL SECTIONS	X
ARCHITECTURE	A-401	ENLARGED TOILET ROOMS	X
ARCHITECTURE	A-501	DETAIL SECTION VIEWS	X
ARCHITECTURE	A-502	DETAIL PLAN VIEWS	X
ARCHITECTURE	A-601	PARTITION TYPES	X
ARCHITECTURE	A-602	ROOM FINISH SCHEDULE & SIGNAGE DETAILS	X
ARCHITECTURE	A-611	DOOR SCHEDULE, DOOR AND WINDOW ELEVATIONS	X

JONESBORO MUNICIPAL
AIRPORT
3901 LINDBERGH DRIVE
JONESBORO, AR 72401

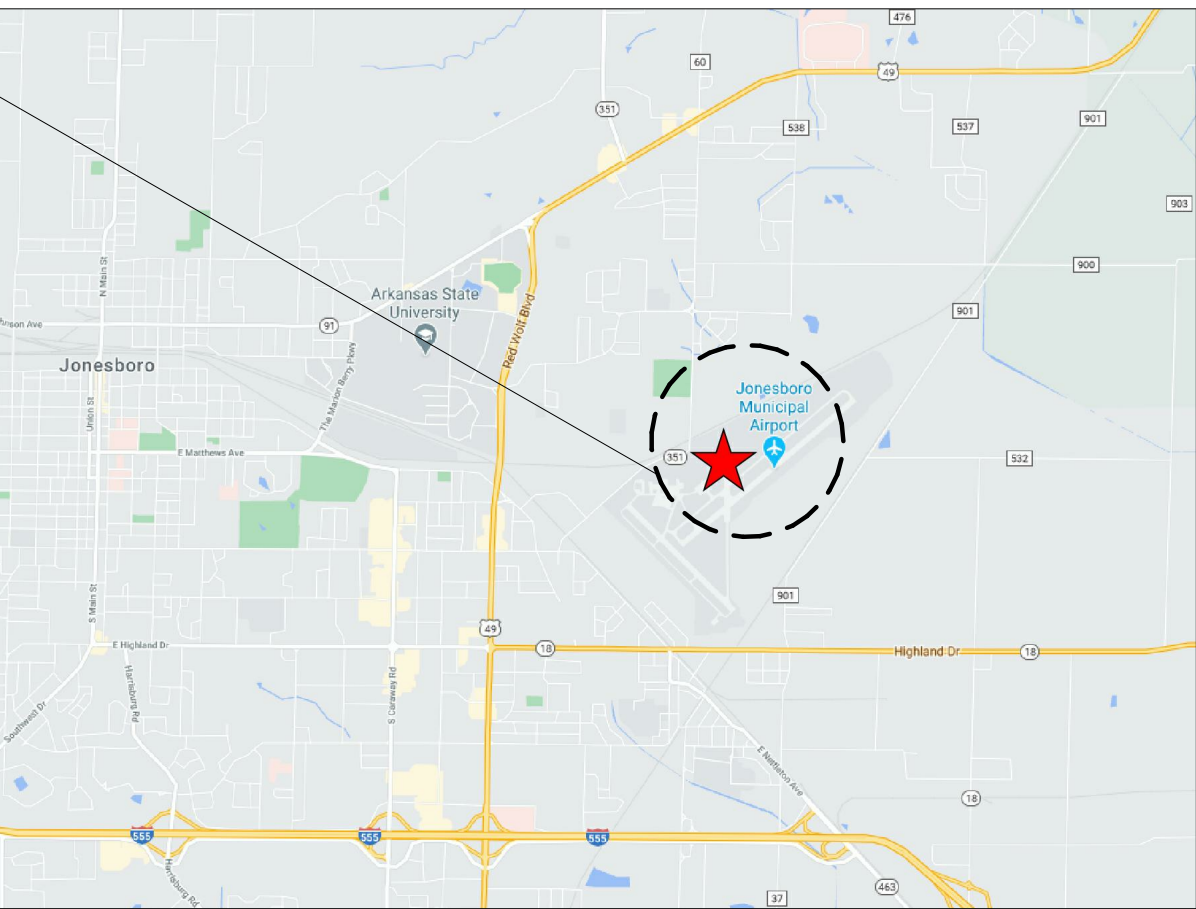

VICINITY MAP
NTS


JONESBORO
MUNICIPAL AIRPORT



LOCATION MAP
NTS

SCHEDULE - SHEET INDEX			
DISCIPLINE	SHEET INFORMATION		SUBMISSIONS CONSTRUCTION SET
	NUMBER	NAME	
ARCHITECTURE	A-612	DOOR HEAD, JAMB, AND SEAL DETAILS	X
ARCHITECTURE	A-613	WINDOW HEAD, JAMB, AND SILL DETAILS	X
FIRE PROTECTION			
FIRE PROTECTION	FP001	FIRE PROTECTION GENERAL NOTES AND DETAILS	X
FIRE PROTECTION	FP101	FLOOR PLAN - FIRE PROTECTION	X
PLUMBING			
PLUMBING	P001	PLUMBING GENERAL NOTES AND LEGEND	X
PLUMBING	P101	FLOOR PLAN - SANITARY SEWER AND VENT	X
PLUMBING	P102	FLOOR PLAN - DOMESTIC WATER	X
PLUMBING	P103	FLOOR PLAN - NATURAL GAS	X
PLUMBING	P201	PLUMBING RISER DIAGRAMS	X
PLUMBING	P202	PLUMBING RISER DIAGRAMS	X
PLUMBING	P203	PLUMBING RISER DIAGRAMS	X
PLUMBING	P301	PLUMBING DETAILS	X
PLUMBING	P401	PLUMBING SCHEDULES	X
MECHANICAL			
MECHANICAL	M001	MECHANICAL GENERAL NOTES AND LEGEND	X
MECHANICAL	M101	FLOOR PLAN - HVAC DUCTWORK	X
MECHANICAL	M201	MECHANICAL DETAILS	X
MECHANICAL	M202	MECHANICAL DETAILS	X
MECHANICAL	M203	MECHANICAL DETAILS	X
MECHANICAL	M301	MECHANICAL SCHEDULES	X
ELECTRICAL			
ELECTRICAL	E001	ELECTRICAL GENERAL NOTES AND LEGEND	X
ELECTRICAL	E101	FLOOR PLAN - LIGHTING	X
ELECTRICAL	E102	FLOOR PLAN - POWER AND SYSTEMS	X
ELECTRICAL	E201	ELECTRICAL DETAILS AND DIAGRAMS	X
ELECTRICAL	E301	ELECTRICAL SCHEDULES	X


Michael Baker
INTERNATIONAL
1501 LBJ FREEWAY,
SUITE 650
DALLAS, TX 75234

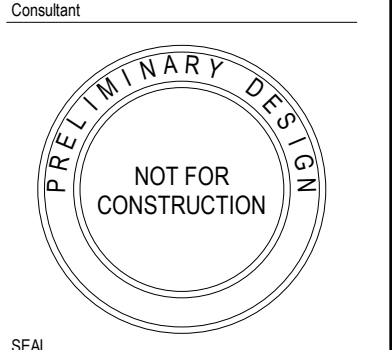

REVISIONS			
NO.	DATE	DESCRIPTION	
2	03/23/2021	ADDENDUM #2	
1	03/16/2021	ADDENDUM #1	

COVER SHEET			
HANGAR REPLACEMENT 3001 EARHART DRIVE JONESBORO, AR 72401			
CONSTRUCTION SET			
Project Number: 181261			
Date: 02-05-2021			
Scale: AS NOTED			
Sheet # G-001			
© Baker 2021			

A
B
C
D

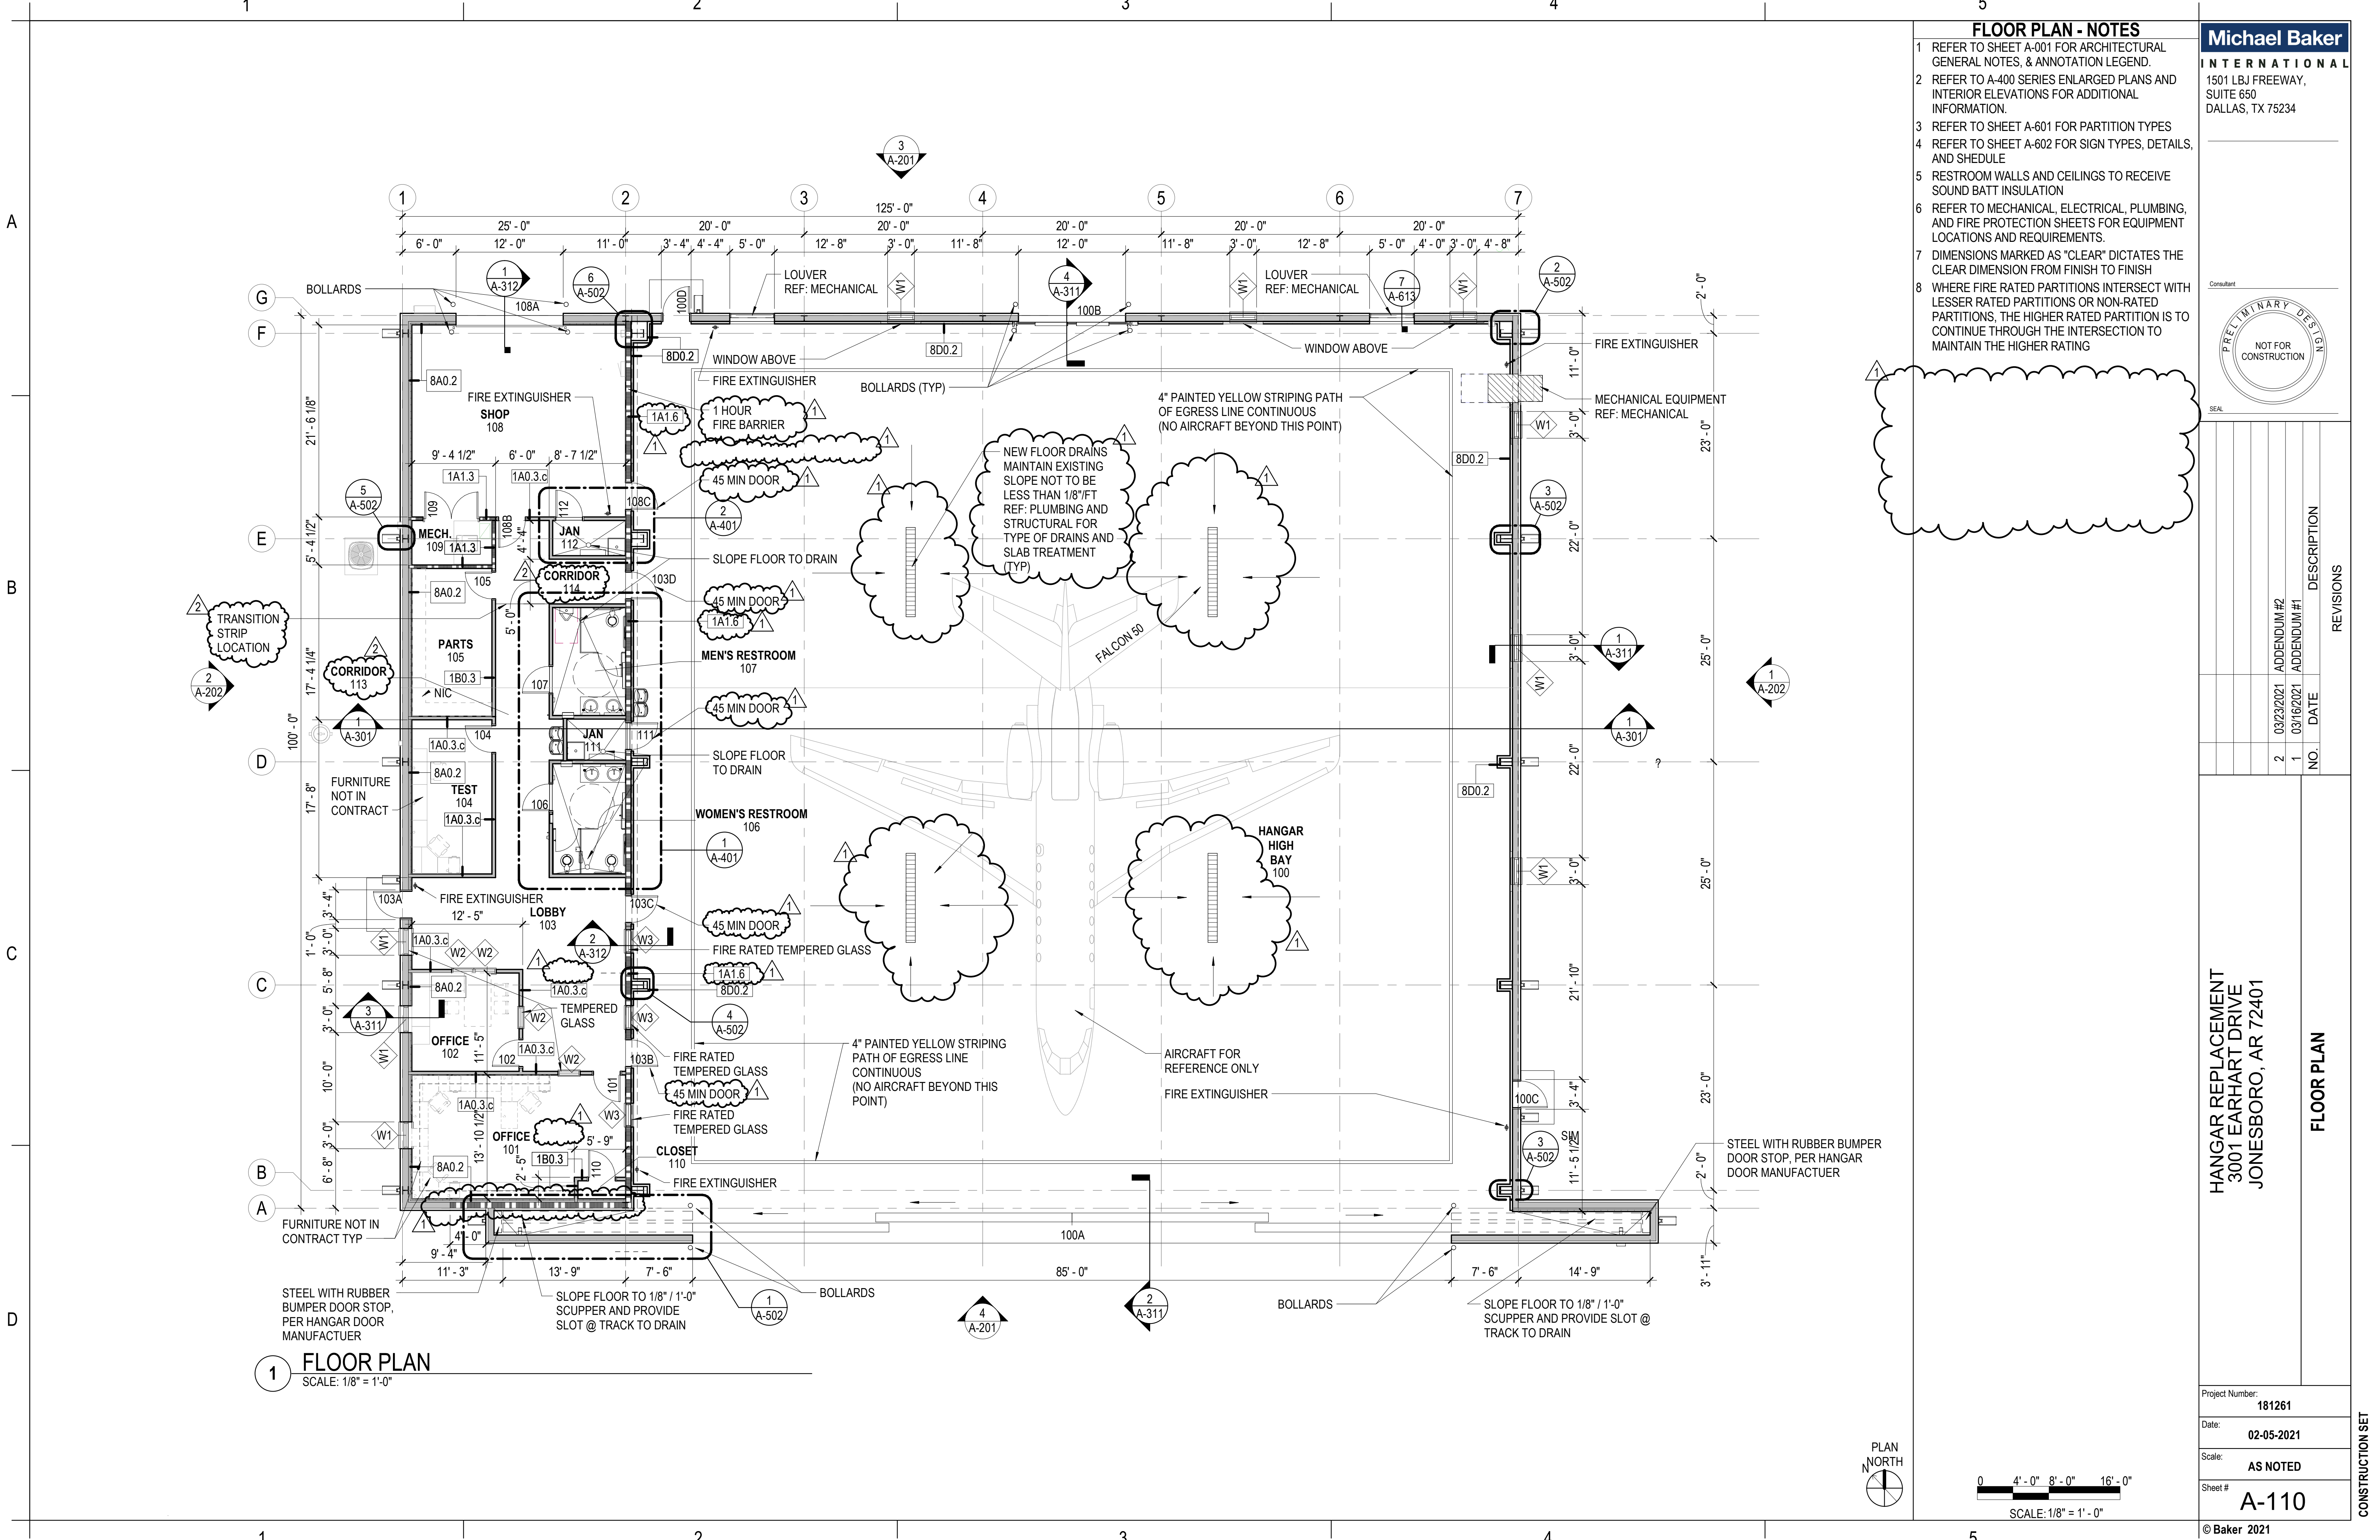

- FLOOR PLAN - NOTES**
- 1 REFER TO SHEET A-001 FOR ARCHITECTURAL GENERAL NOTES, & ANNOTATION LEGEND.
 - 2 REFER TO A-400 SERIES ENLARGED PLANS AND INTERIOR ELEVATIONS FOR ADDITIONAL INFORMATION.
 - 3 REFER TO SHEET A-601 FOR PARTITION TYPES
 - 4 REFER TO SHEET A-602 FOR SIGN TYPES, DETAILS, AND SHEDULE
 - 5 RESTROOM WALLS AND CEILINGS TO RECEIVE SOUND BATT INSULATION
 - 6 REFER TO MECHANICAL, ELECTRICAL, PLUMBING, AND FIRE PROTECTION SHEETS FOR EQUIPMENT LOCATIONS AND REQUIREMENTS.
 - 7 DIMENSIONS MARKED AS "CLEAR" DICTATES THE CLEAR DIMENSION FROM FINISH TO FINISH
 - 8 WHERE FIRE RATED PARTITIONS INTERSECT WITH LESSER RATED PARTITIONS OR NON-RATED PARTITIONS, THE HIGHER RATED PARTITION IS TO CONTINUE THROUGH THE INTERSECTION TO MAINTAIN THE HIGHER RATING

Michael Baker INTERNATIONAL
1501 LBJ FREEWAY,
SUITE 650
DALLAS, TX 75234

Consultant

PRELIMINARY DESIGN
NOT FOR CONSTRUCTION

SEAL

REVISIONS		DESCRIPTION
NO.	DATE	
2	03/23/2021	ADDENDUM #2
1	03/16/2021	ADDENDUM #1

**HANGAR REPLACEMENT
3001 EARHART DRIVE
JONESBORO, AR 72401**

FLOOR PLAN

Project Number: **181261**

Date: **02-05-2021**

Scale: **AS NOTED**

Sheet # **A-110**

© Baker 2021

PLAN NORTH

0 4' - 0" 8' - 0" 16' - 0"

SCALE: 1/8" = 1' - 0"

CONSTRUCTION SET



SCALE:NTS

REFER TO SHEET A-002 FOR MOUNTING HEIGHTS
AND LOCATION RELATIVE TO DOORS



SCALE:NTS

REFER TO SHEET A-002 FOR MOUNTING HEIGHTS
AND LOCATION RELATIVE TO DOORS



SCALE:NTS

ALL RESTROOM EXITS & EXTERIOR EXITS



SCALE:NTS

ALL ROOMS SHALL HAVE ID SIGNS @ DOORS



SCALE:NTS

ALL EGREES DOORS WITH PANIC DEVICES



SCALE: 3/4" = 1'-0"

REFER TO SHEET G-102 FOR LOCATIONS


LEGEND - FINISH	
ACT	ACOUSTICAL CEILING TILE
CONC-S	CONCRETE - SEALED
CPT	CARPET
CT-1	CERAMIC TILE
GB-P	GYPSUM BOARD PAINTED
LP	LINER PANEL
P	PAINTED
STR	EXPOSED STRUCTURE
STR-P	EXPOSED STRUCTURE - PAINTED
VB	4" VINYL BASE
VCT	VINYL COMPOSITION TILE
VI	VINYL INSULATION

LEGEND - FINISH

ACT	ACOUSTICAL CEILING TILE
CONC-S	CONCRETE - SEALED
CPT	CARPET
CT-1	CERAMIC TILE
GB-P	GYPSUM BOARD PAINTED
LP	LINER PANEL
P	PAINTED
STR	EXPOSED STRUCTURE
STR-P	EXPOSED STRUCTURE - PAINTED
VB	4" VINYL BASE
VCT	VINYL COMPOSITION TILE
VI	VINYL INSULATION

NOTES:

1. REFER TO WALL TYPES AND CEILING PLAN FOR SOUND BATT INSULATION REQUIREMENTS

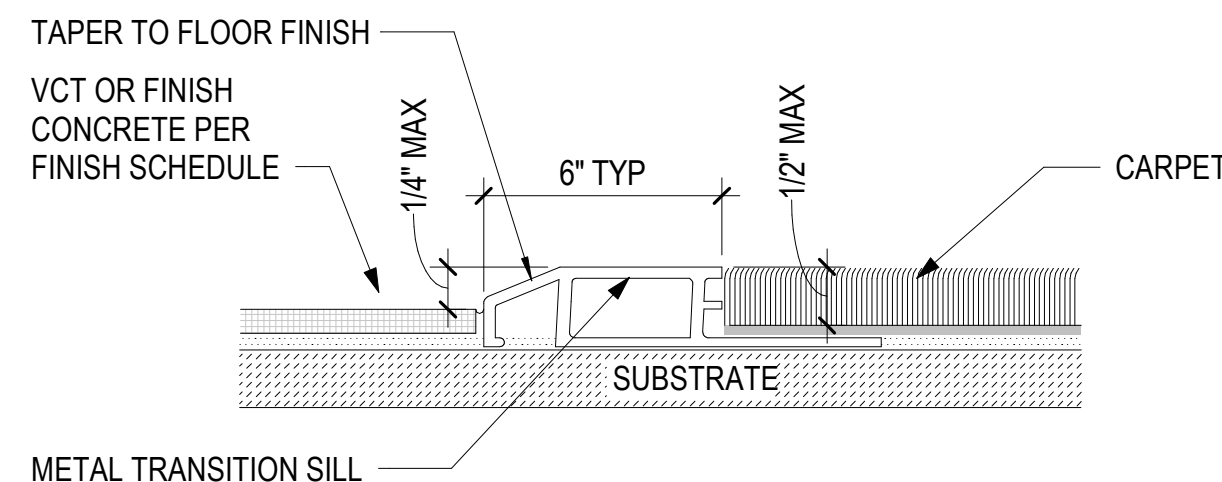

FINISH DETAIL - INTERIOR TRANSITION STRIPS


SCALE:NTS



INTERNATIONAL

1501 LBJ FREEWAY,
SUITE 650
DALLAS, TX 75234

Consultant

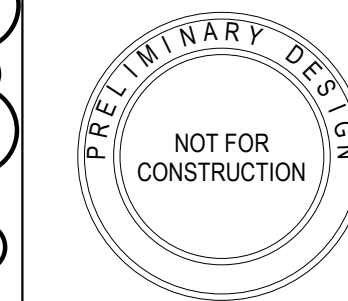

SEA

[illegible]

HANGAR REPLACEMENT
3001 EARHART DRIVE
JONESBORO, AR 72401

ROOM FINISH SCHEDULE & SIGNAGE DETAILS

Project Number: 181261

Date: 02-05-2021

Scale: **AS NOTED**

Sheet # **A-602**

© Baker 2021

[illegible]